
 


 












 





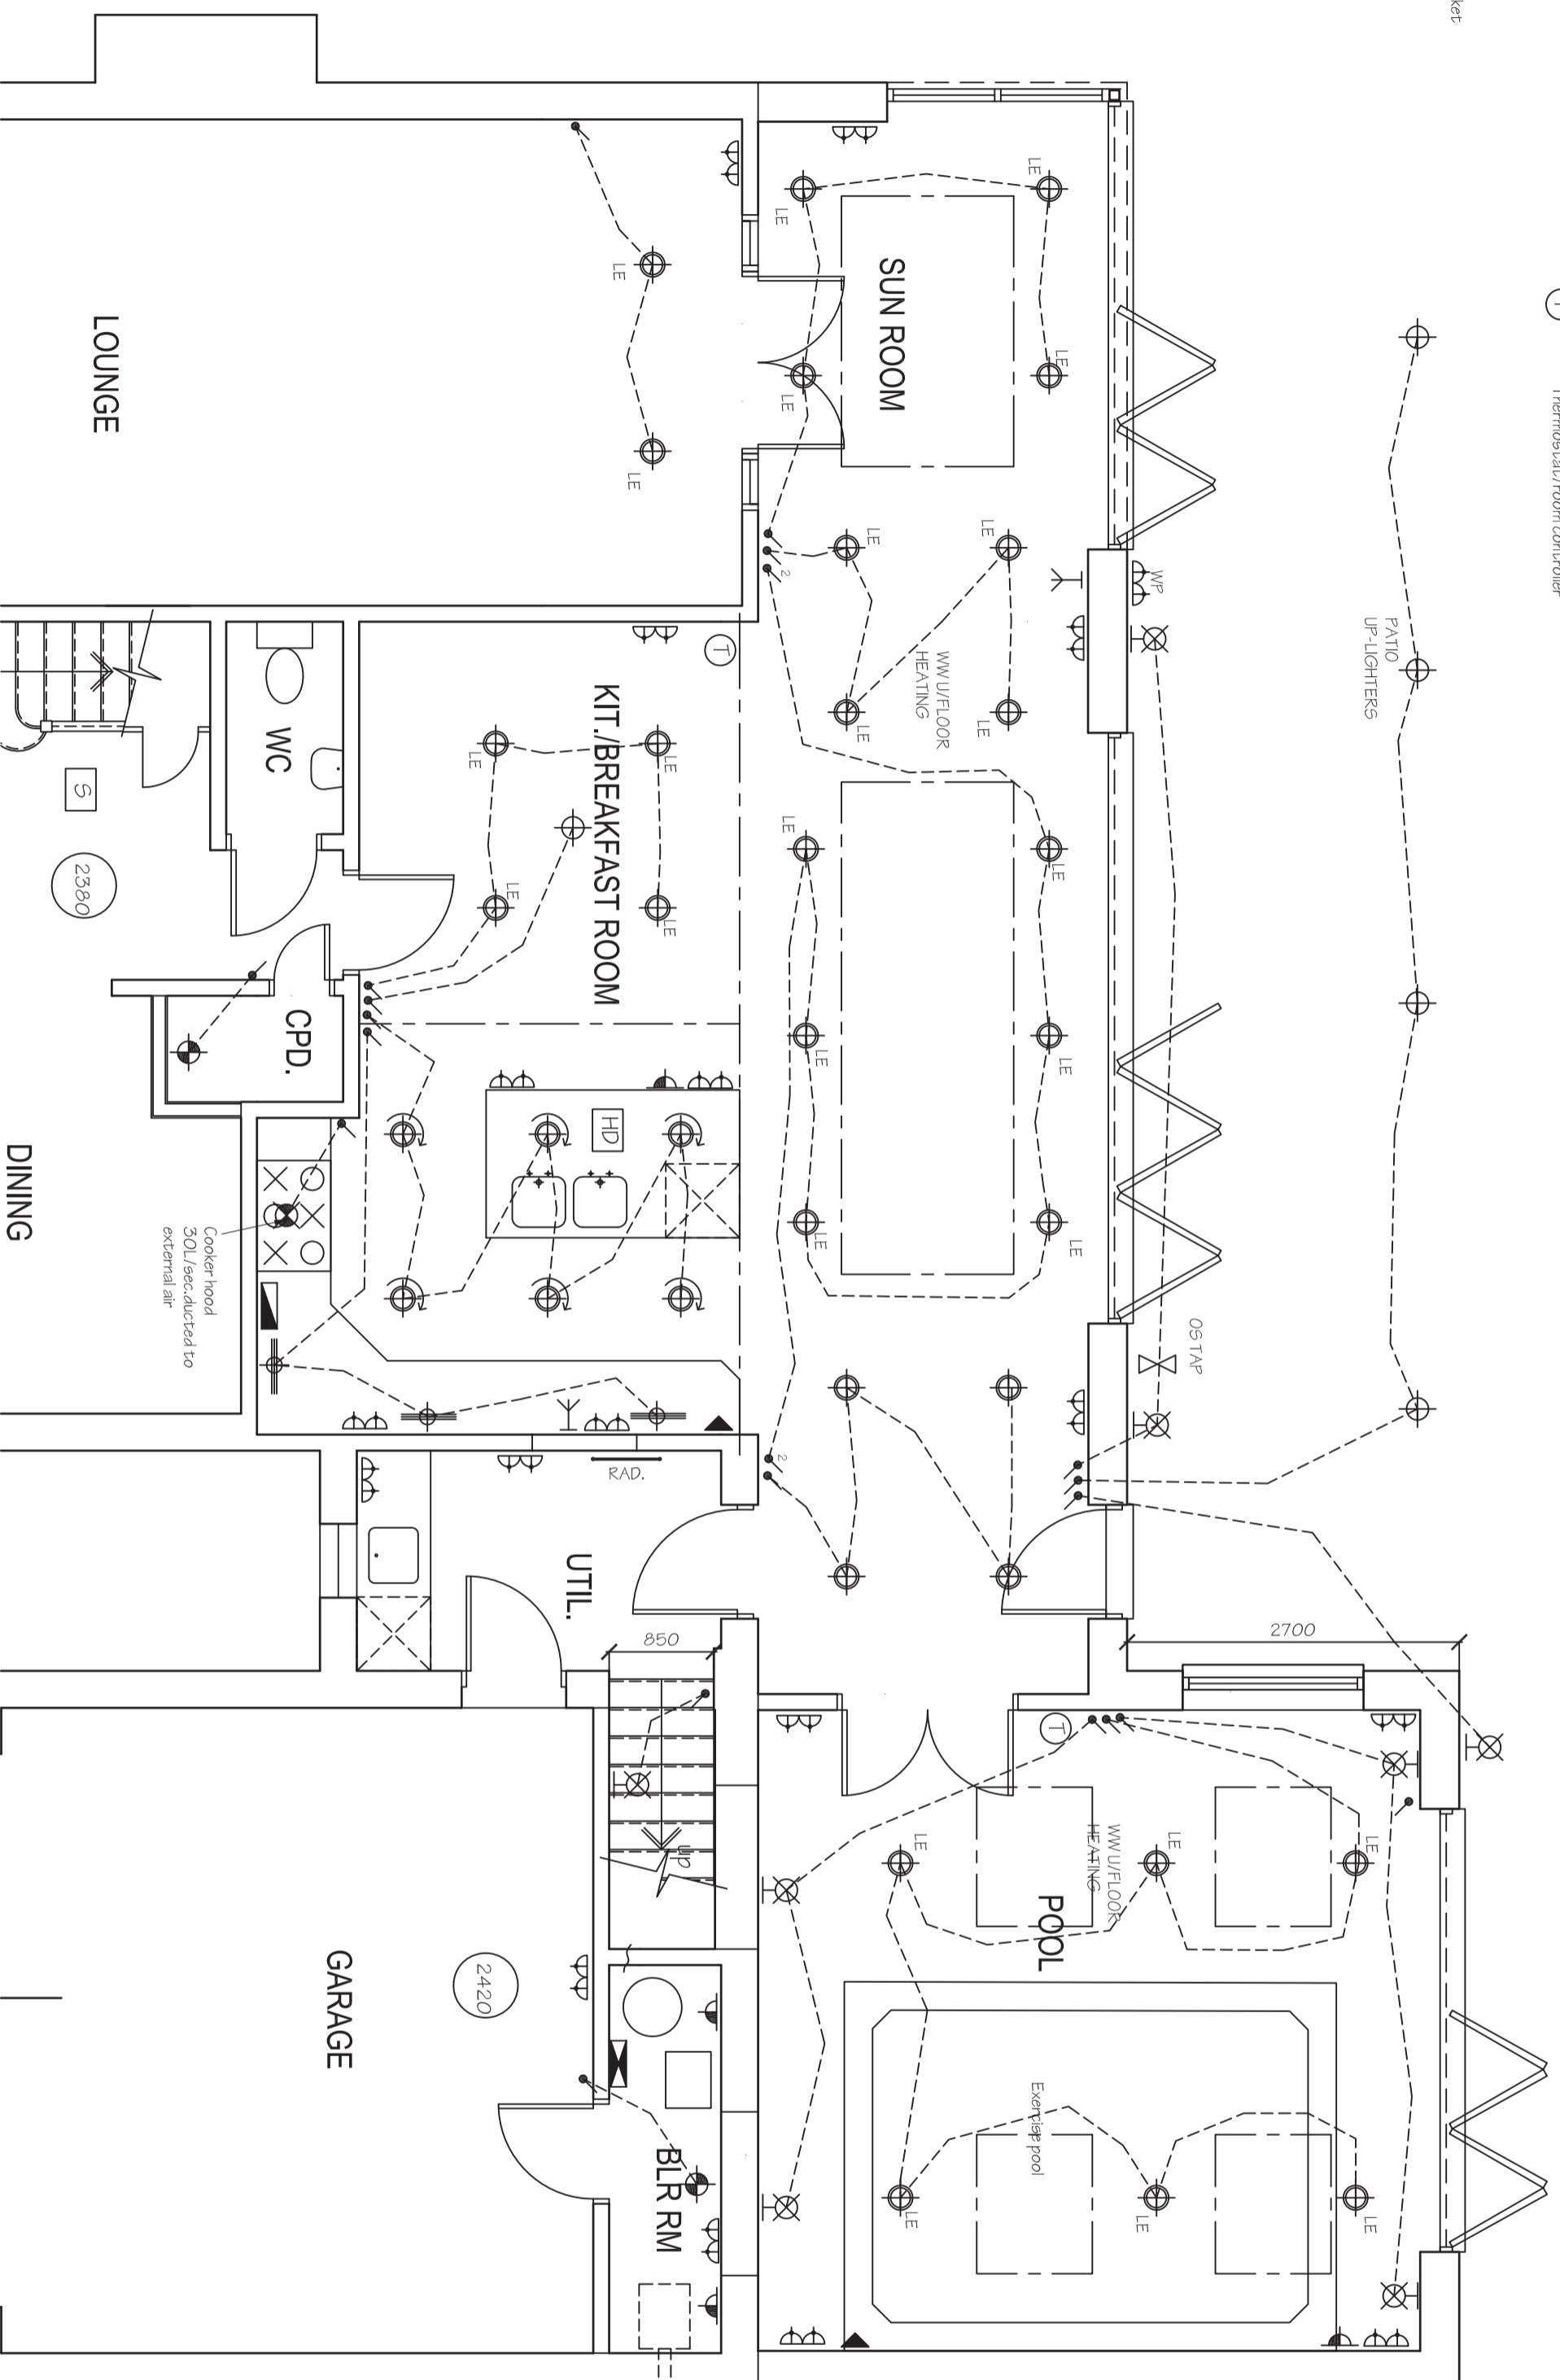


### KEY TO ELECTRICAL SYMBOLS

-  13A switched socket outlet
-  Weatherproof outside socket outlet
-  Ceiling rose with 300mm fix and lamp holder
-  Recessed downlighter
-  Eyeball recessed downlighter
-  4-pin CFL low energy/light fitting in lampholder - luminous efficacy greater than 40 lumens per circuit-watt
-  Splashproof light fitting
-  Battem lamp holder with skirt
-  External bulkhead light fitting with 4-pin CFL low energy lamp or light fitting with FR daylight detector
-  Two-way switch
-  Switch
-  Dimmer switch
-  Dual voltage shaver socket
-  45a cooker control unit
-  Consumer unit
-  Telephone point
-  Coaxial TV aerial / satellite TV point
-  Spur outlet for appliance with accessible isolator switch
-  Kitchen wall unit pelmet light fitting
-  Mains-operated smoke detector to BS 5839: part 1 interconnected and wired to separate fused circuit at distribution board
-  Mains-operated heat detector to BS 5839: part 1 interconnected and wired to separate fused circuit at distribution board
-  Mechanical extract fan or cooker hood
-  Thermostat/room controller



### GROUND FLOOR PLAN

**Notes:**

All dimensions must be checked on site and not scaled from this drawing.

All work must be carried out in accordance with statutory requirements, all relevant British Standards and codes of practice.

No.	Date	Revisions


  
**mn8 property consultants**
  
gchitectural design construction management

the studio, headley road, grayshott, surrey, GU26 4JG  
 e: [dab@mn8propertyconsultants.co.uk](mailto:dab@mn8propertyconsultants.co.uk) t: 01428 713075  
 w: [mn8propertyconsultants.co.uk](http://mn8propertyconsultants.co.uk) m: 07856 677660

Client  
 Job Title  
**HASLEMERE SURREY**

Drawing Title  
**PROPOSED EXTENSION SERVICES LAYOUT**

Scale  
 1:50  
 Sheet size  
 A2

Date  
 DEC 12

Dwg No  
 11711/04